



Morehouse Hall
1202 28th Street

Fire Extinguisher: 15 Total

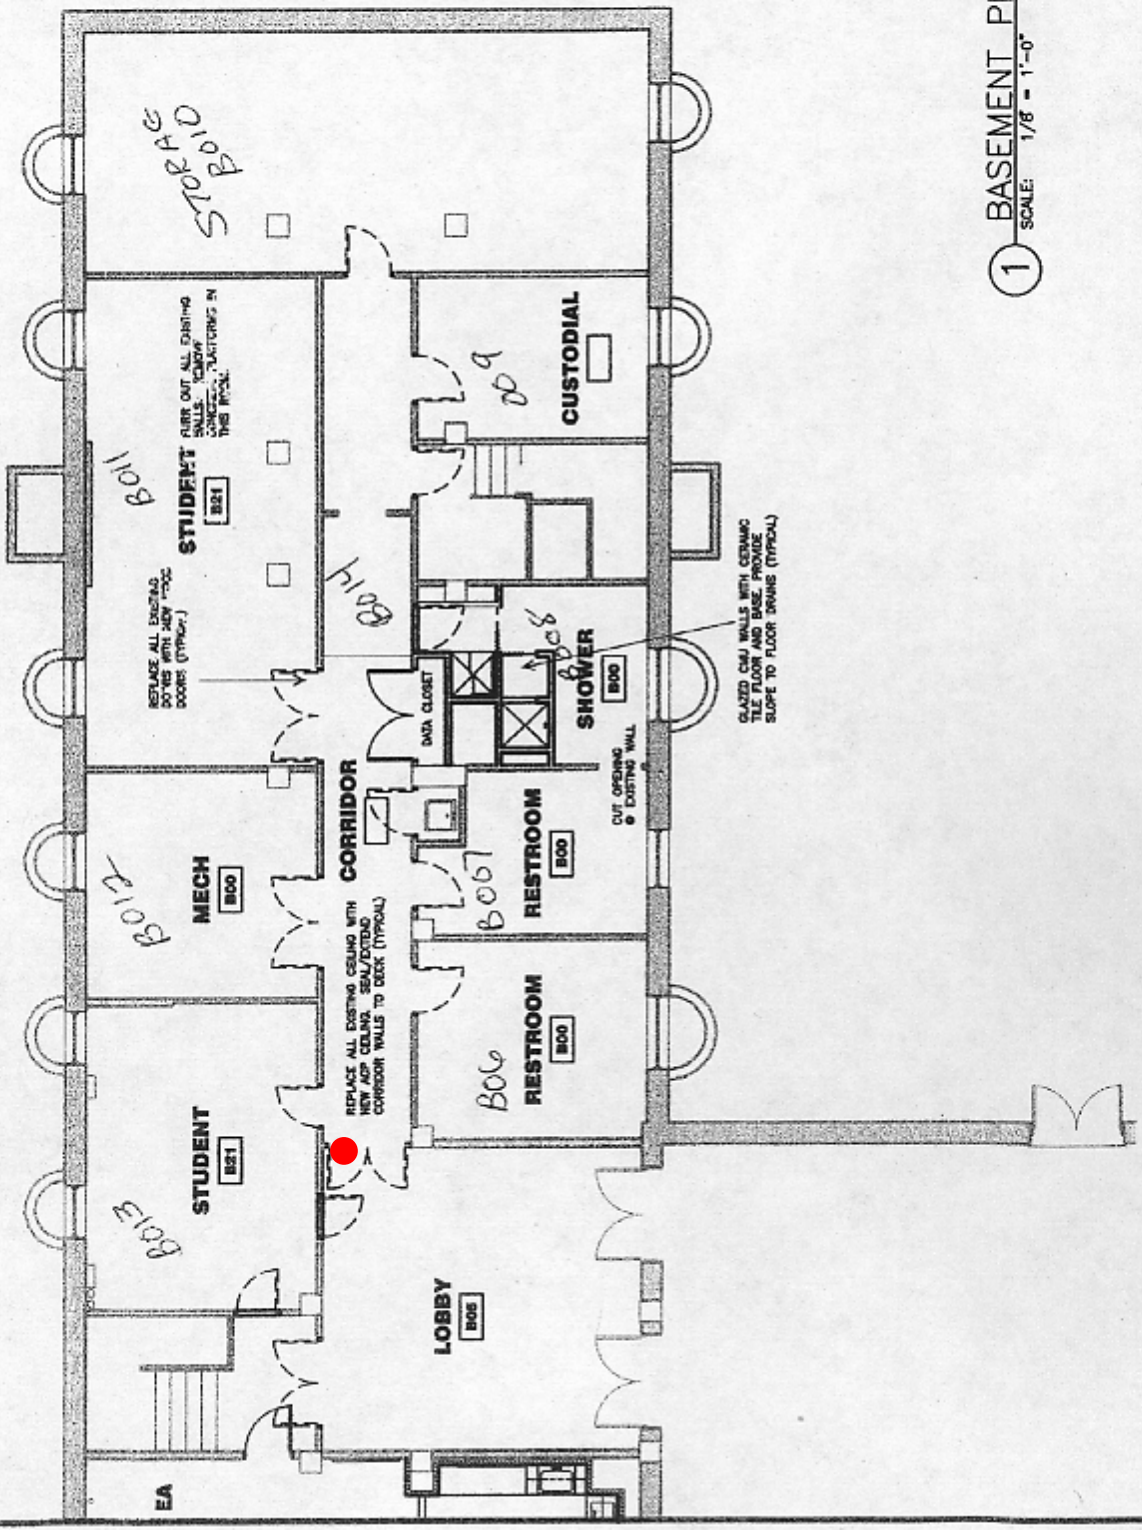

1 BASEMENT PLAN
SCALE: 1/8" = 1'-0"

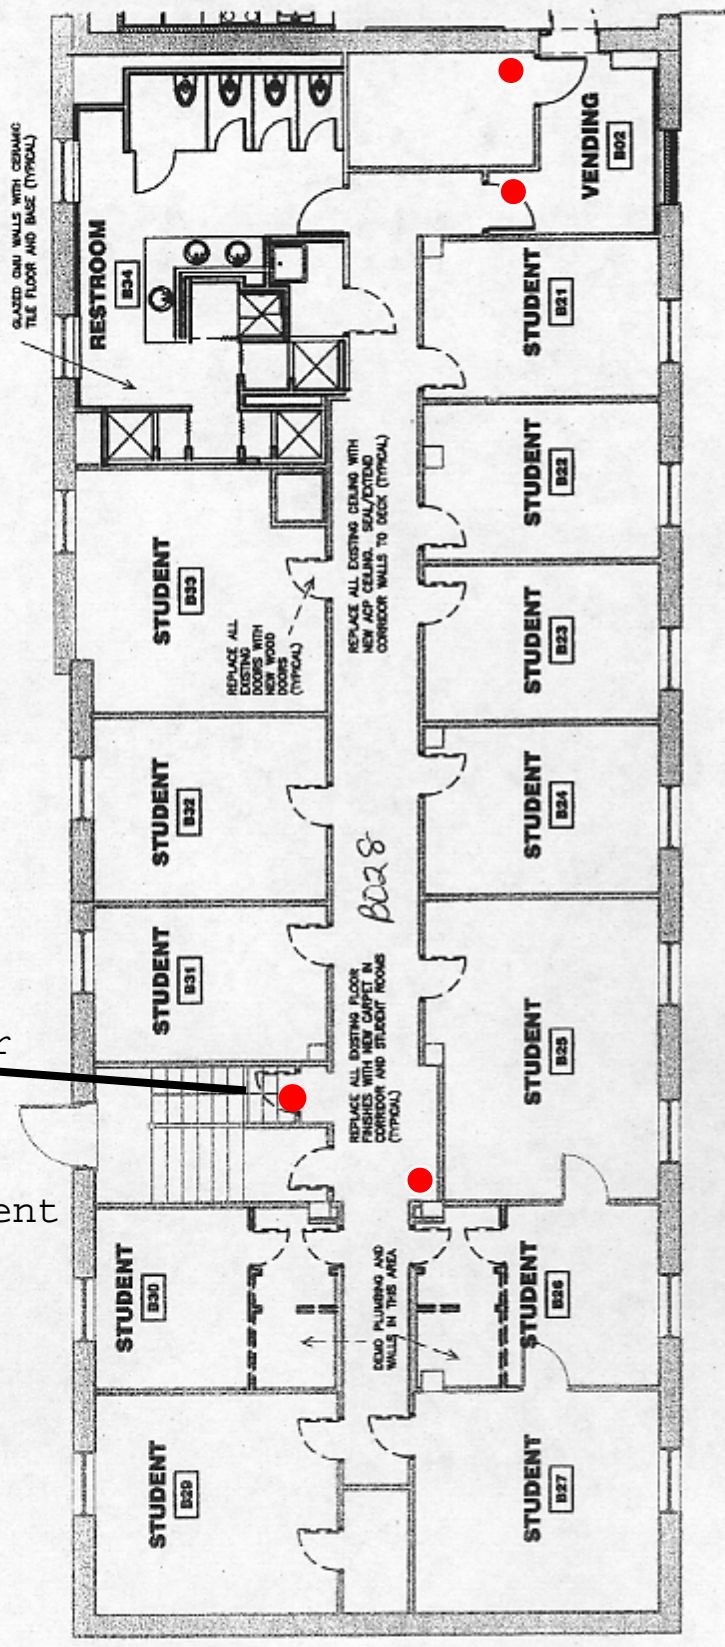



Boiler
Room
in
Basement

1 BASEMENT PLAN
SCALE: 1/8" = 1'-0"



1 BASEMENT PLAN
SCALE: 3/16" = 1'-0"

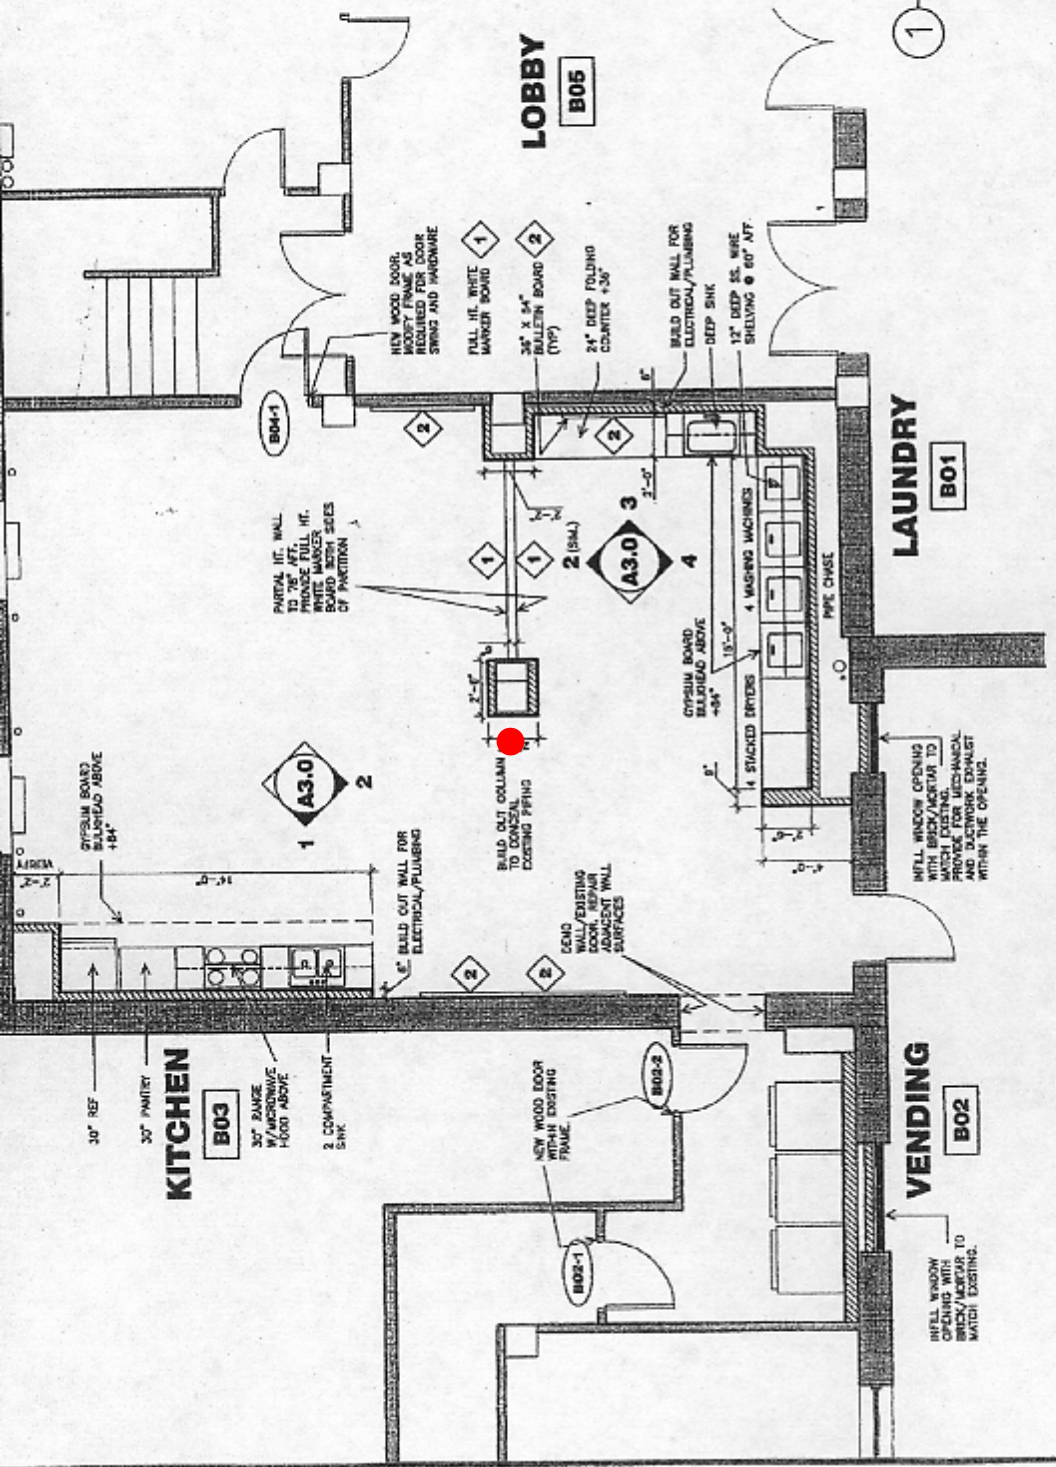


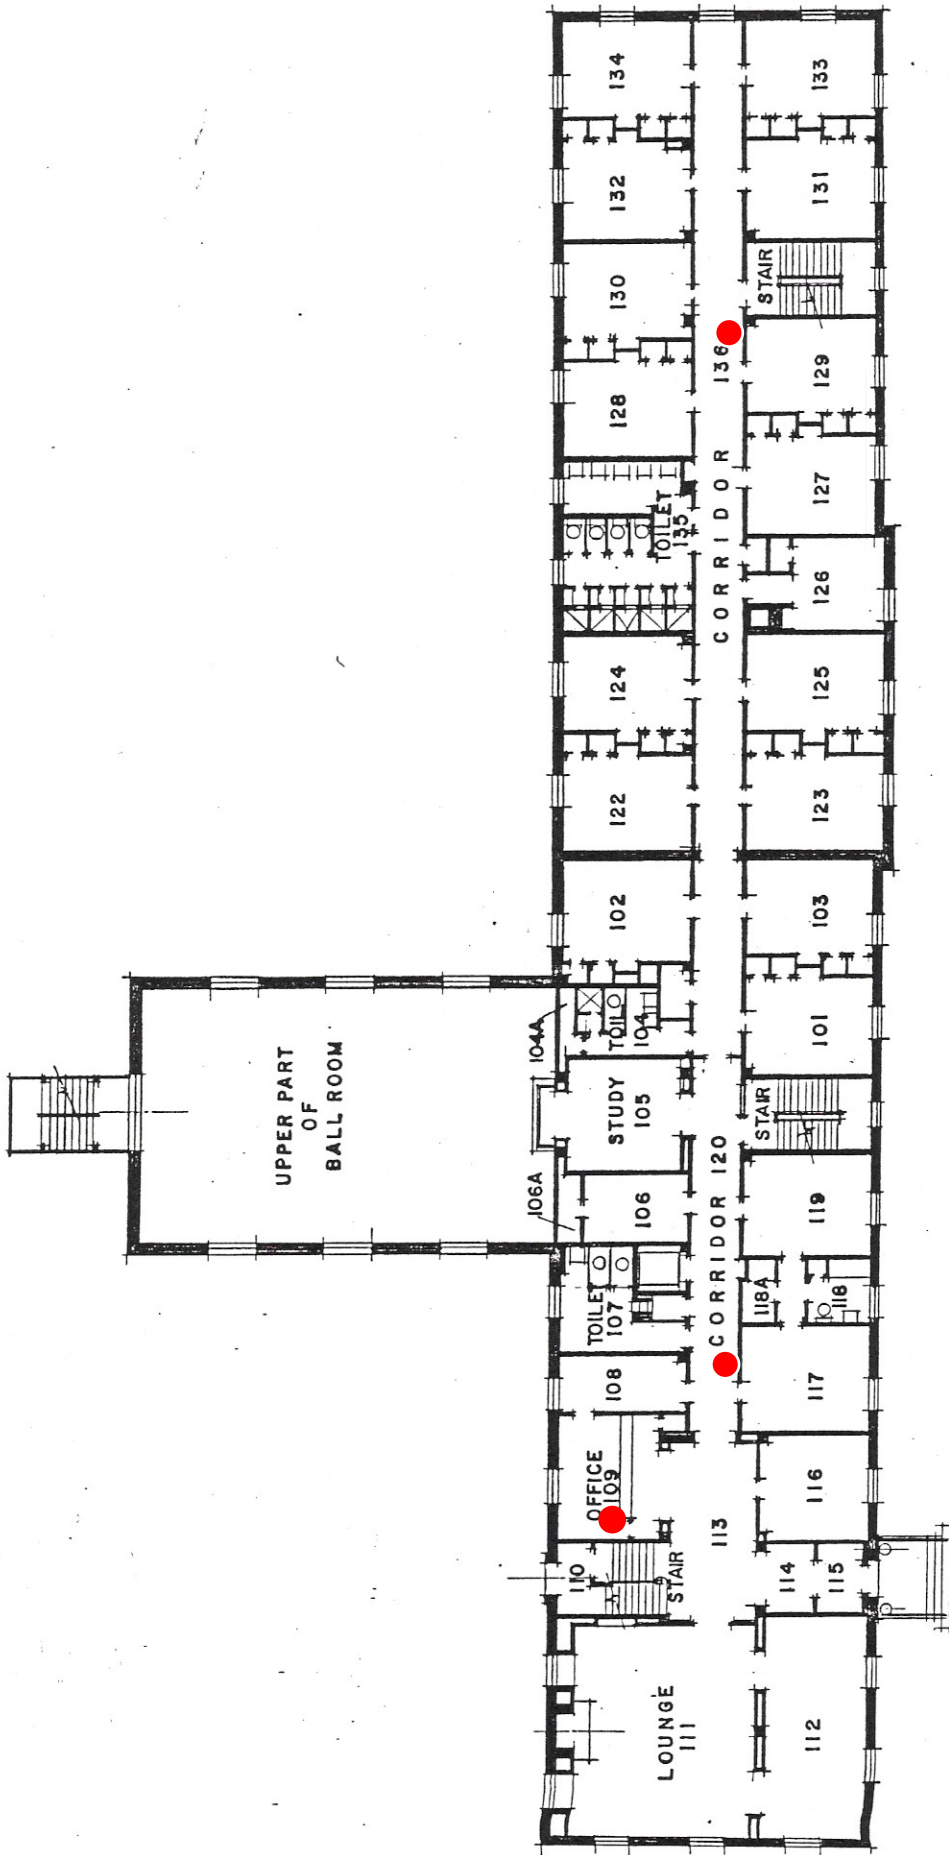


FIRST FLOOR PLAN




MOREHOUSE HALL
DRAKE UNIVERSITY

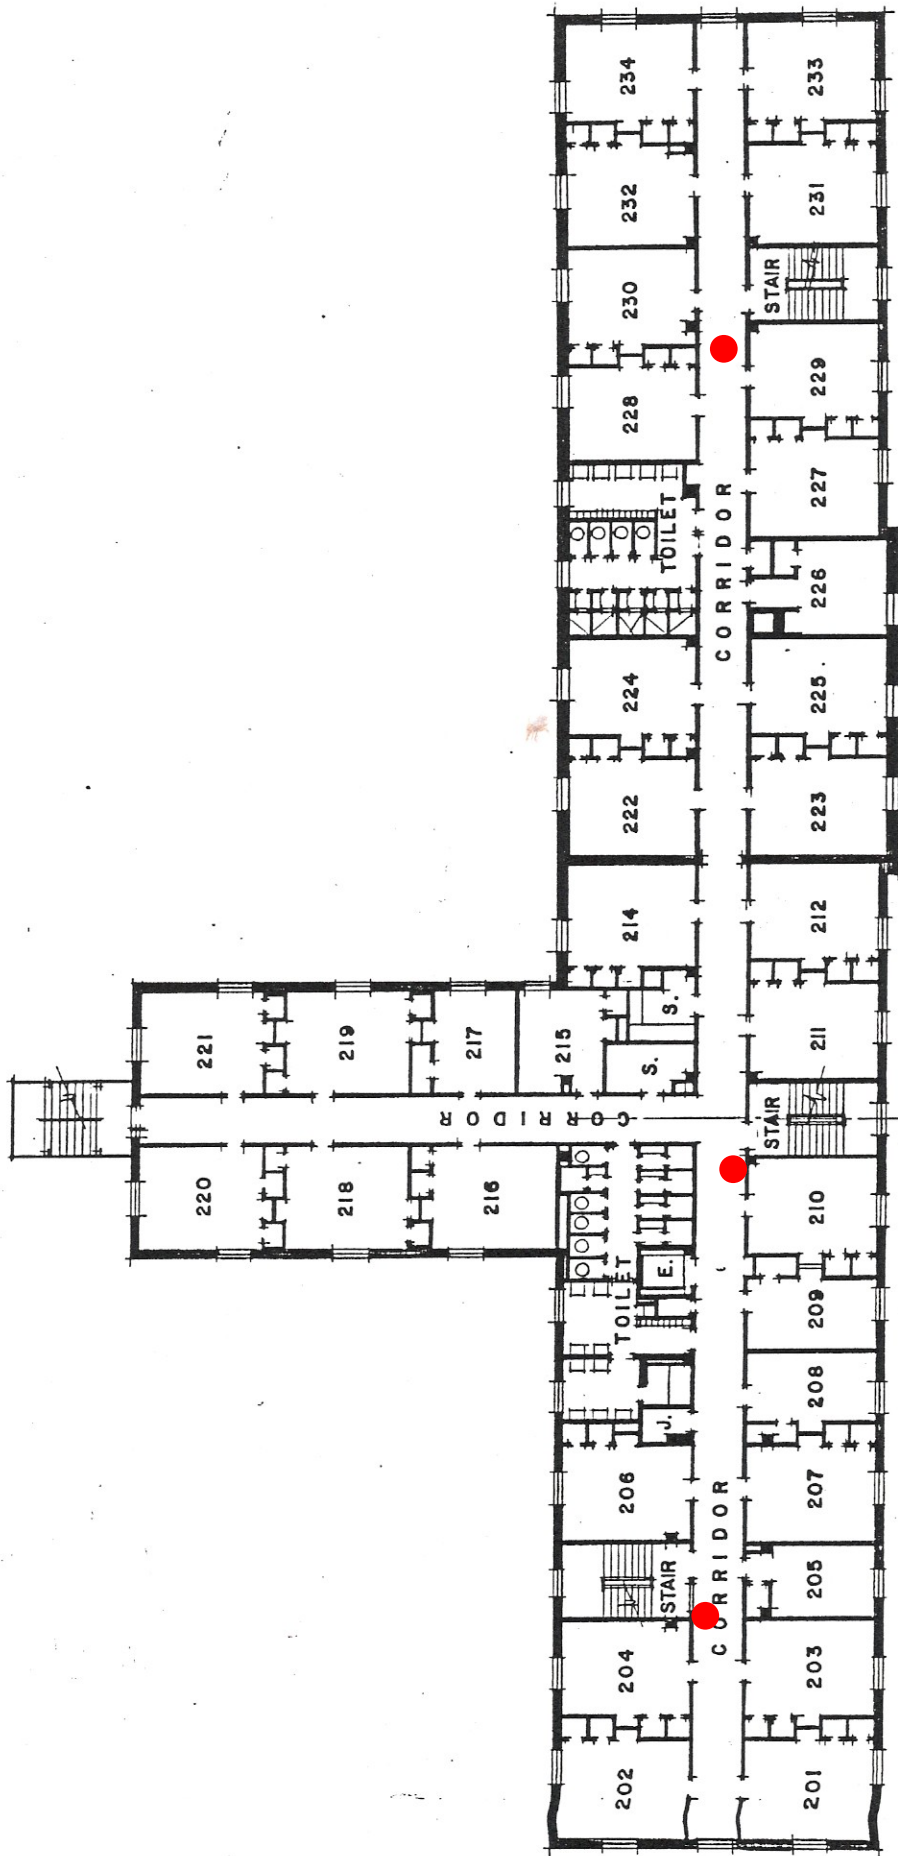

SECOND FLOOR PLAN

 

MOREHOUSE HALL
 DRAKE UNIVERSITY

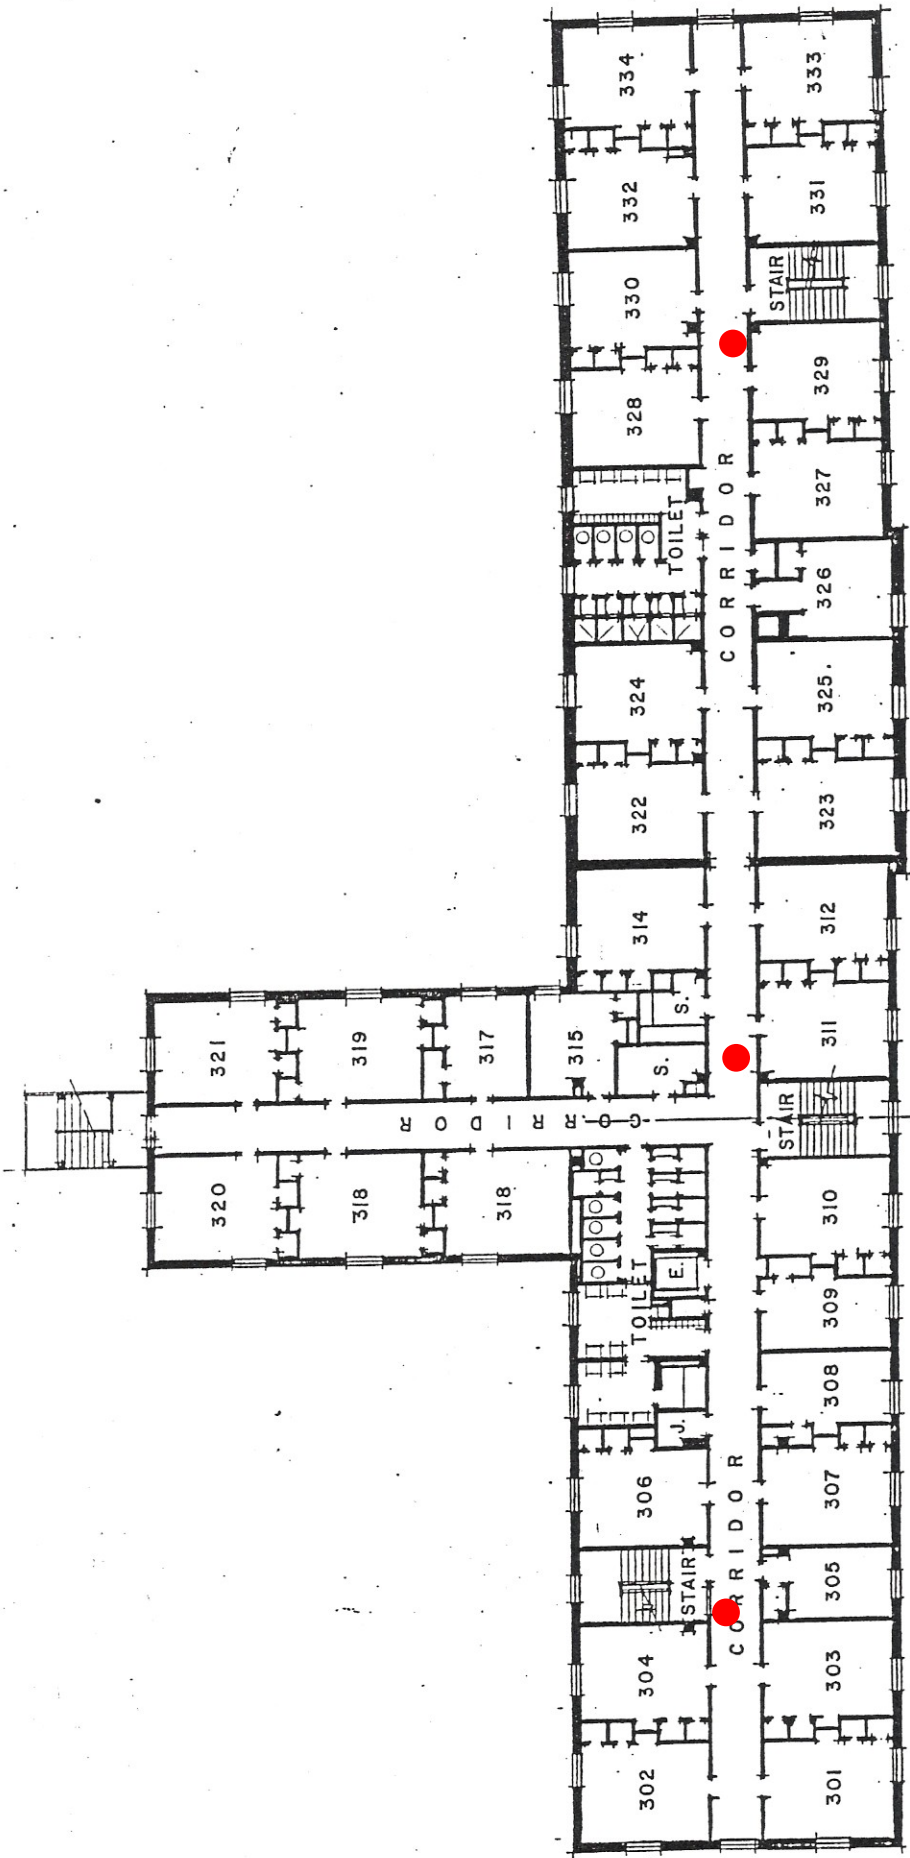

THIRD FLOOR PLAN

